



SCHNITT A-A

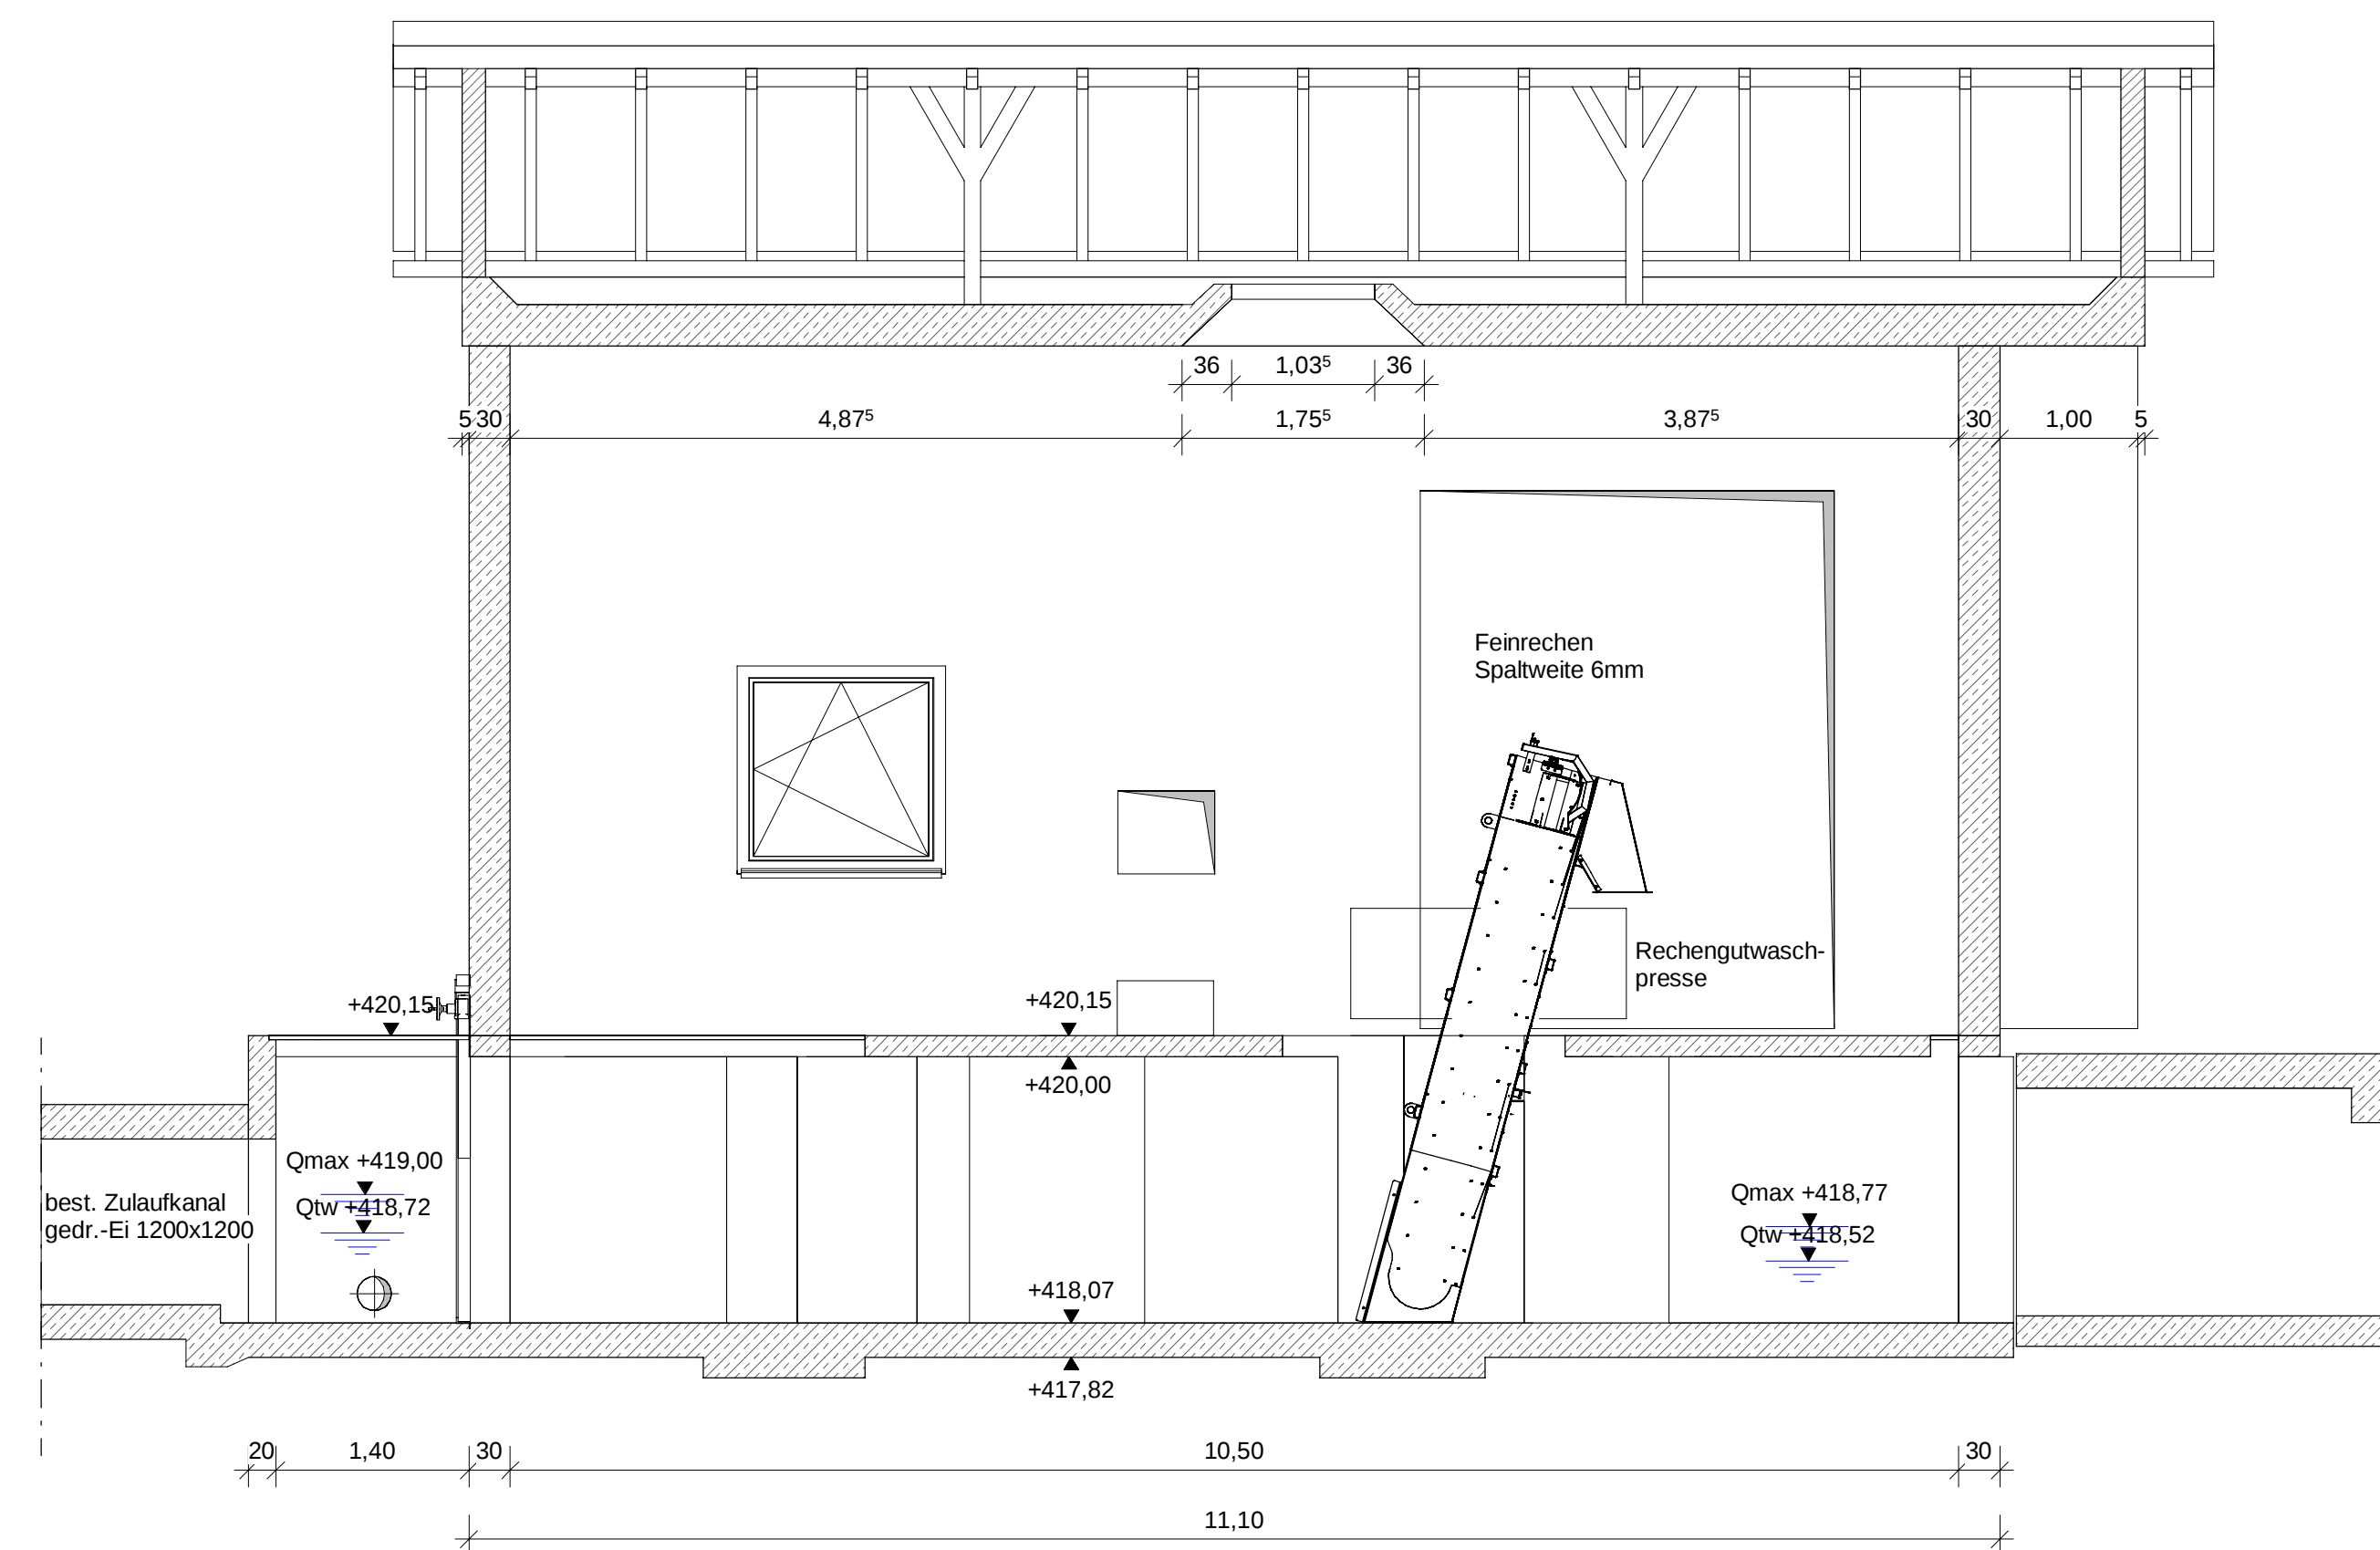

Technical drawing of a wall section showing construction details and dimensions. The drawing includes a cross-section of a wall with various layers and components. Key features include:

- Dimensions:**
 - Horizontal dimensions: 20, 1.40, 30, 1.60, 10.50, 30.
 - Vertical dimensions: +418.07, +417.82.
- Labels and Notes:**
 - gepl. 2. Feinrechen, Spaltweite 6mm
 - Grobrechen demontieren
 - gepl. Stackschieber bH=1200/1800
 - gepl. Stackschieber bH=1200/1800
- Structural Elements:**
 - Reinforcement bars (dashed lines) and concrete structure (hatched areas).
 - Windows or openings on either side of the wall section.

SCHNITT B-B

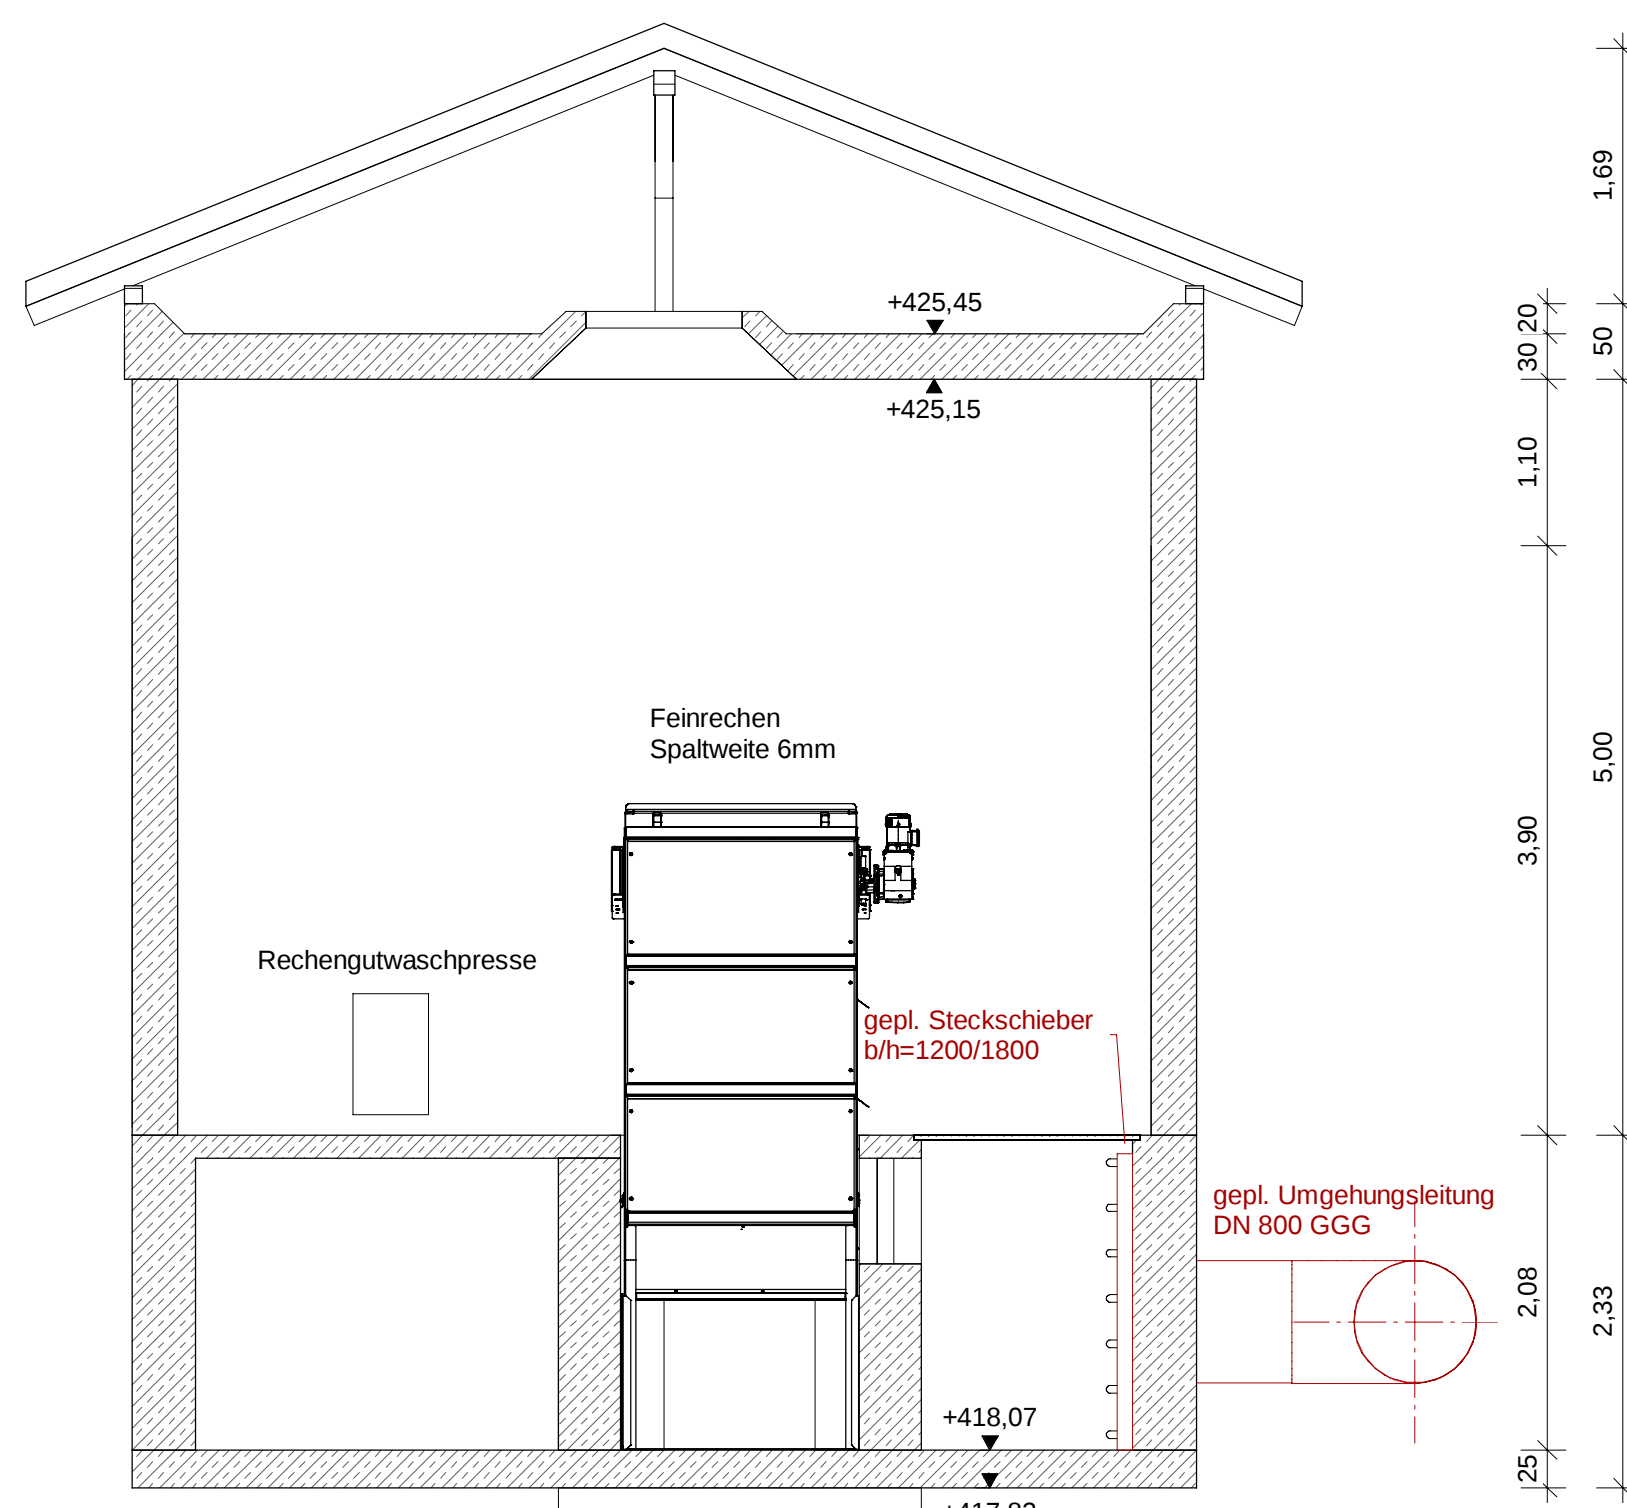

04			
03			
02			
01			
Index	Datum	Name	Bemerkung
Bauherr Stadtwerke Pfaffenhofen a. d. Ilm  STADTWERKE PFAFFENHOFEN A. D. ILM			
Projekt	Kläranlage Pfaffenhofen Erweiterung der Kläranlage		Projekt-Nr. 22965 Bezeichnungen Nr. 4-BE-KA-034-a
Planinhalt	Rechengebäude Grundriss und Schnitte		Maßstab 1:500 Blattgröße A Proband
Entwurfverfasser	 GFM Bau- und Umweltingenieur GmbH Amo-Albers-Strasse 7 80607 München Tel.: 089-380178-0 Fax: 089-380178-30 info@gfm.com http://www.gfm.com		genehmigt Feb. 24 R
			erstellt Feb. 24 S
			geprüft Feb. 24 R
		München, den	